



ELECTRICAL PLAN - MEZZANINE

SCALE: 1/8"=1'-0"

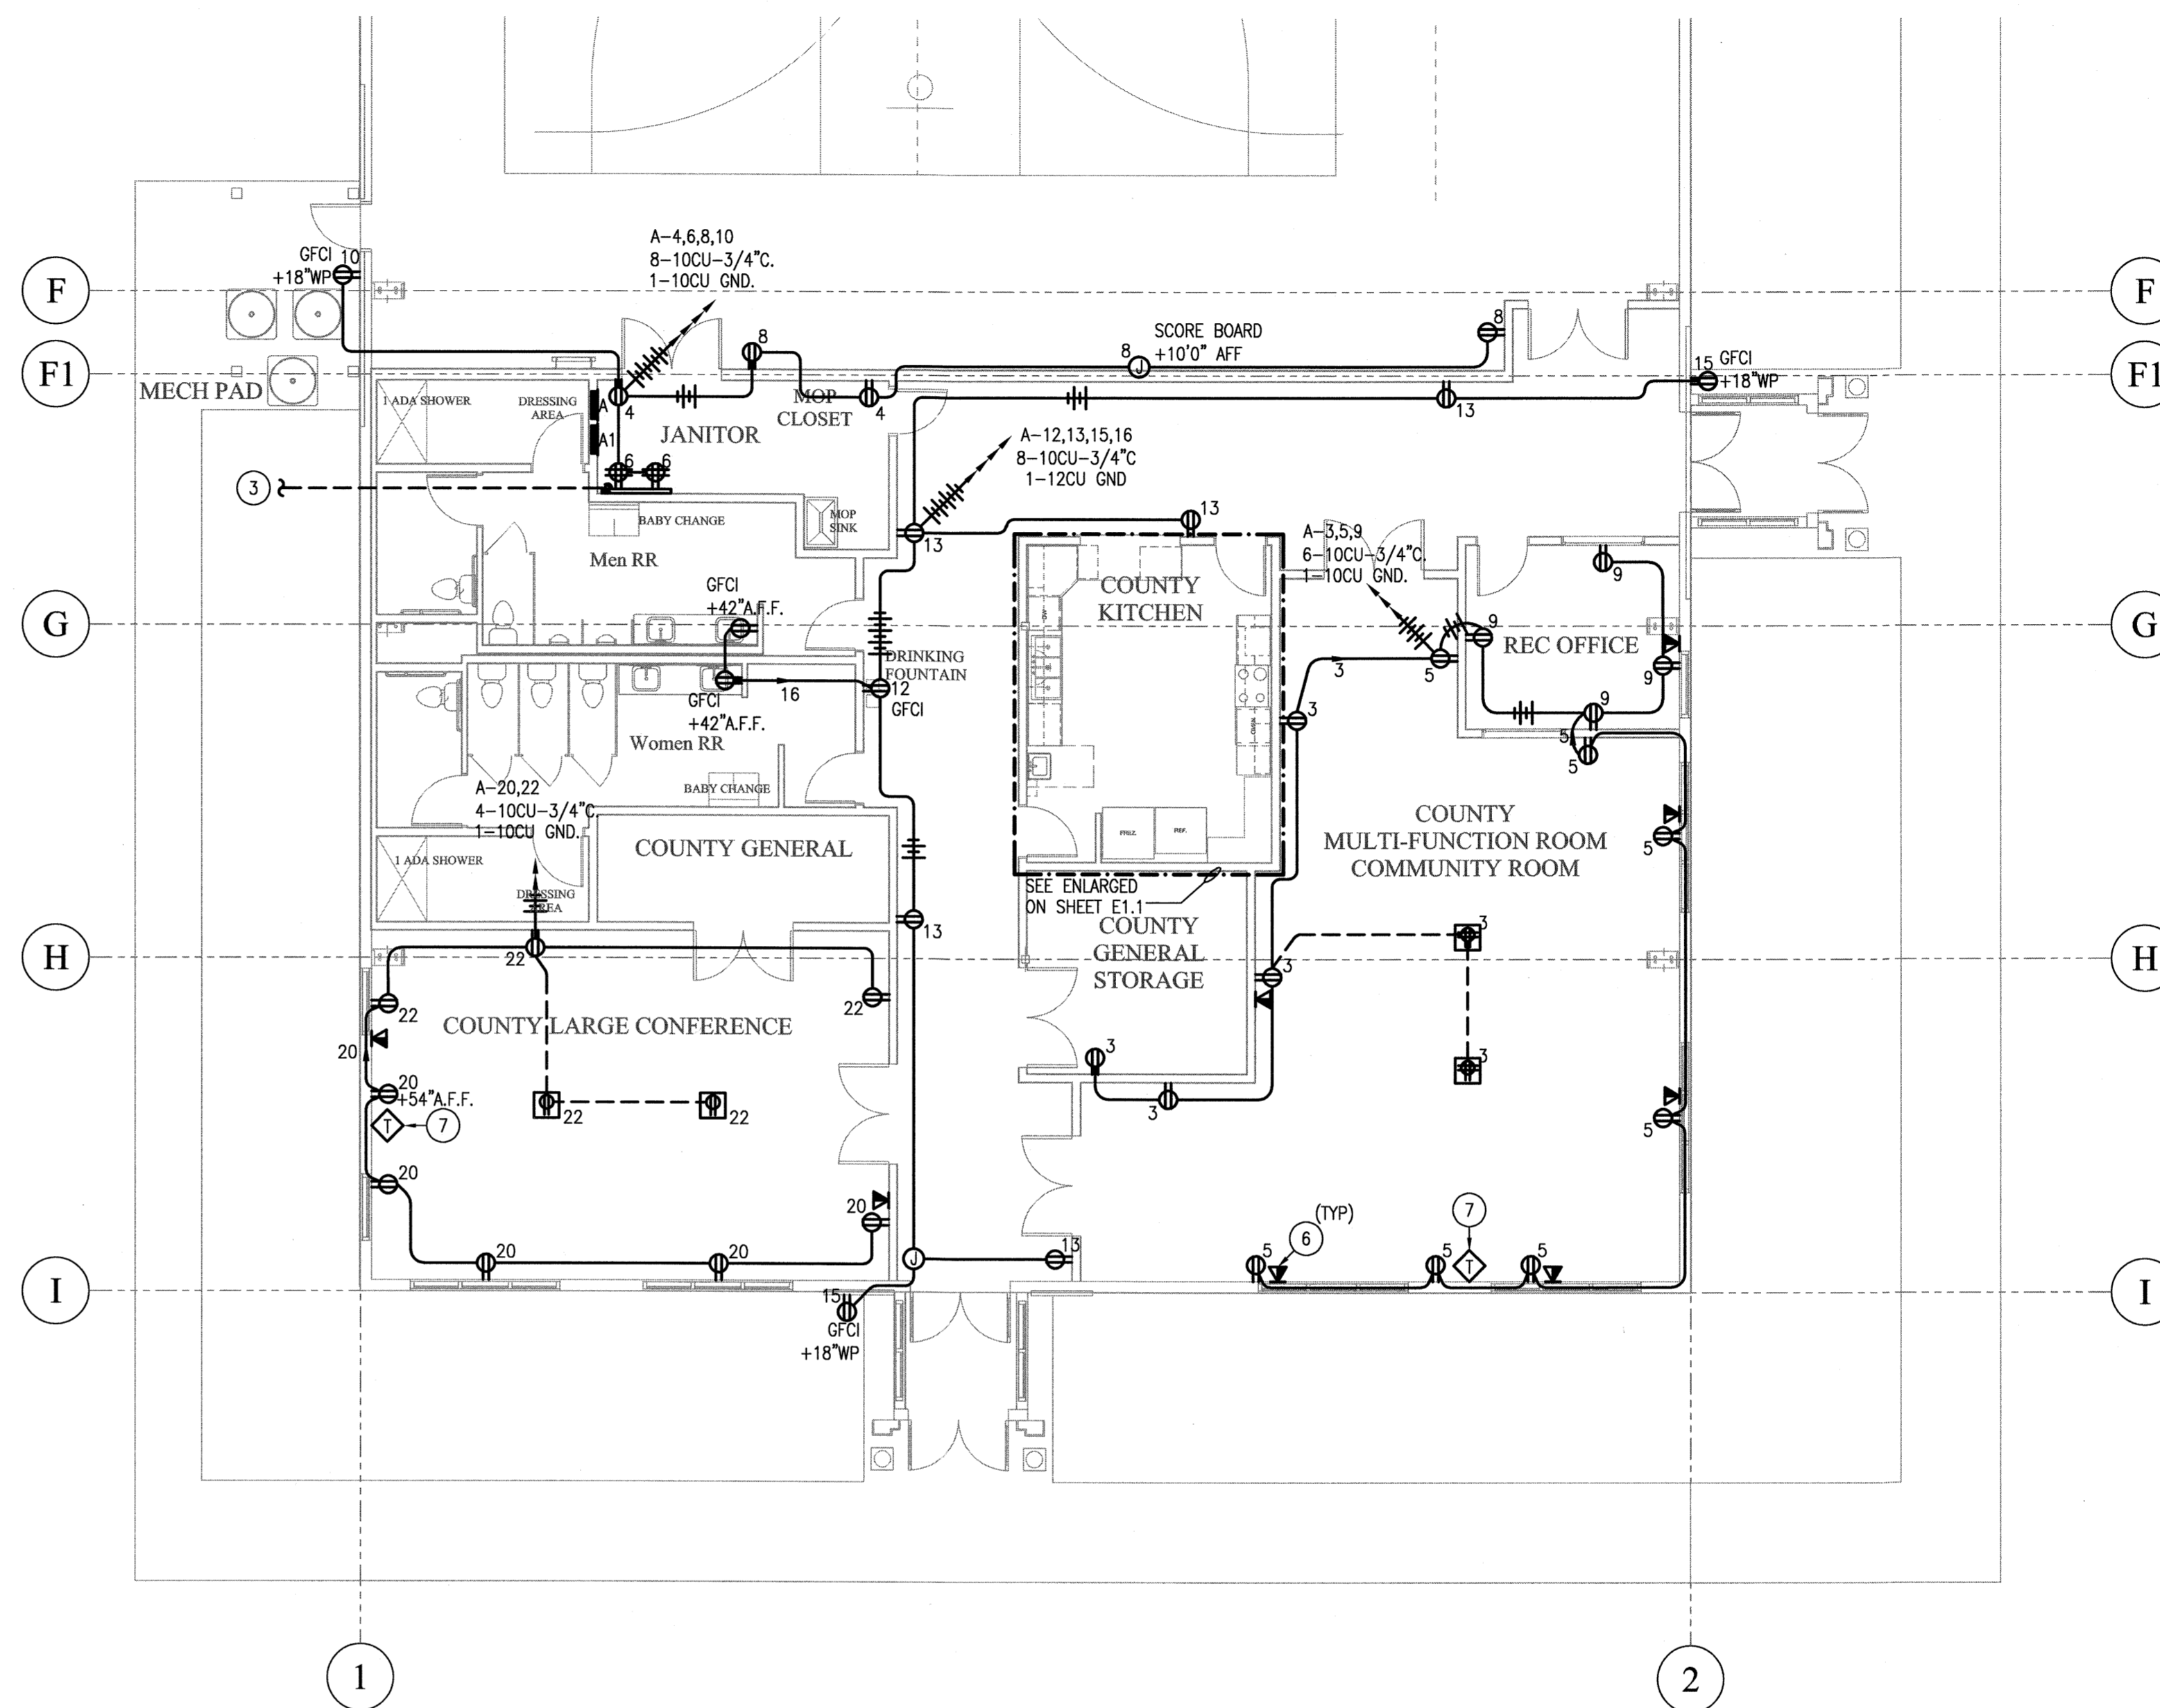

ELECTRICAL PLAN - OFFICES

SCALE: 1/8"=1'-0"

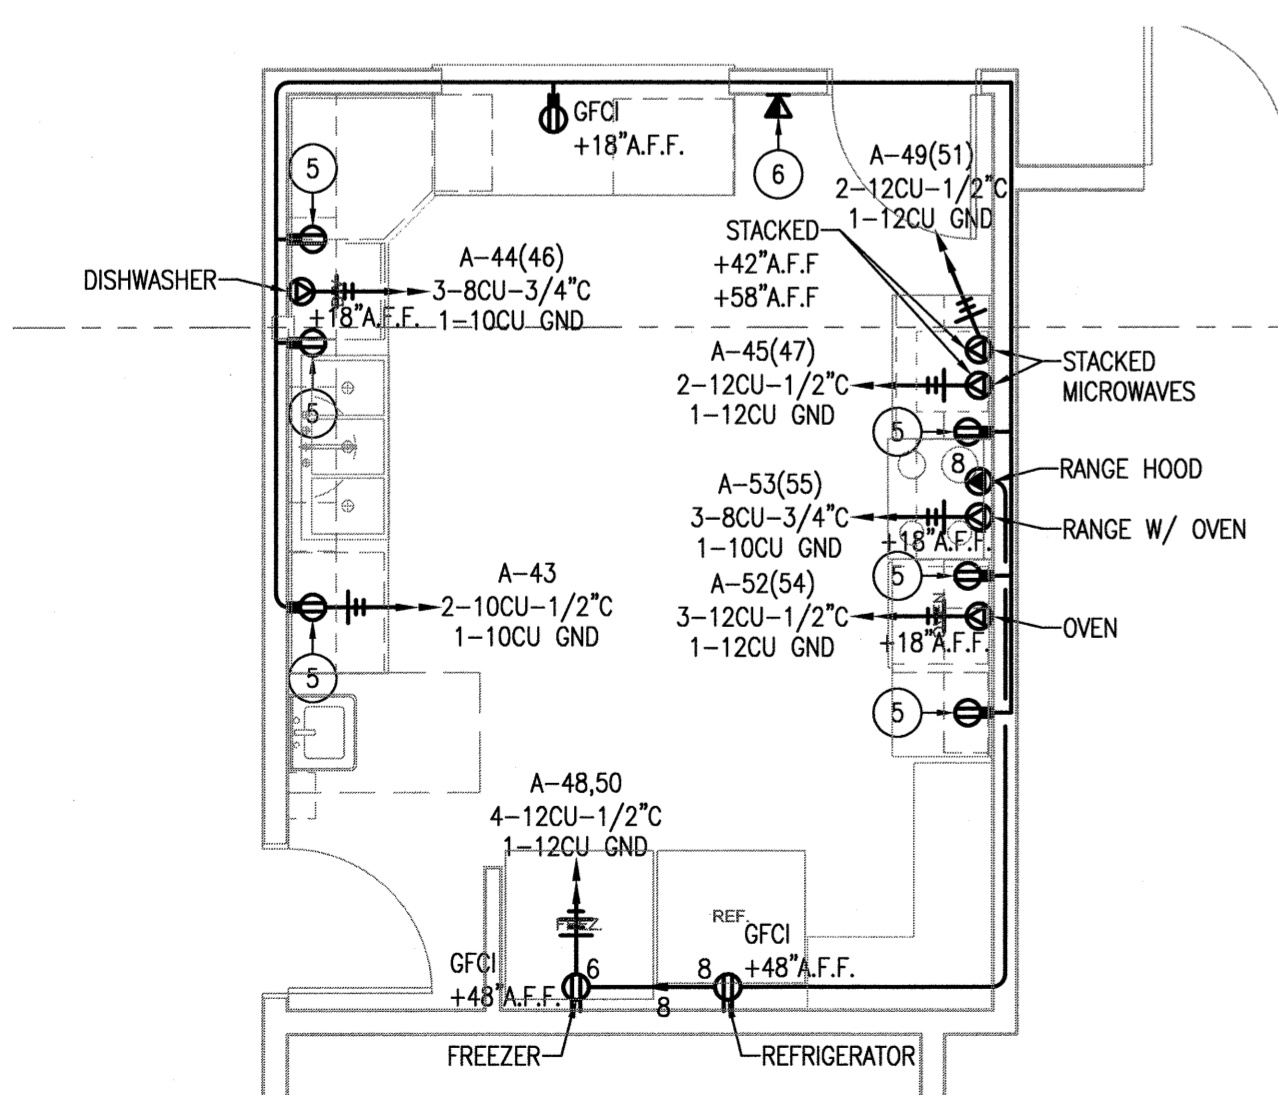


ELECTRICAL PLAN-KITCHEN

SCALE: 1/4"=1'-0"

KEY NOTES:

1. SEE ONE-LINE DIAGRAM ON SHEET E0.0. NEW UTILITY SERVICE FROM UTILITY COMPANY (PCo) POLE DROP TO NEW MAIN DISTRIBUTION PANEL (MDP).
2. SEE ONE-LINE DIAGRAM ON SHEET E0.0. NEW UTILITY METER PER UTILITY COMPANY (PCo) REQUIREMENTS.
3. NEW TELEPHONE SERVICE FROM UTILITY PROVIDER POLE TO NEW TTB BOARD AT THIS LOCATION.
4. COORDINATE LOCATION OF CONVENIENCE OUTLETS WITH FIRE SPRINKLER CONTRACTOR PRIOR TO ROUGH-IN.
5. GFCI KITCHEN CONVENIENCE OUTLETS SHALL BE MOUNTED HORIZONTALLY AT 39" A.F.F. FOR ADA ACCESSIBILITY. ALSO, THEY MUST BE MOUNTED A MINIMUM OF 36" FROM A CORNER.
6. PROVIDE TELE/DATA CAT6 TO TTB.
7. TV CONNECTION. PROVIDE CONNECTOR AT 54" AFF. ROUTE TO TTB LOCATION.

TRW Architecture Planning
 515 EAST PARKWAY CT.
 Boise, Idaho 83706
 208.371.9298
 trw@trwarchitecture.com
 www.trwarchitecture.com

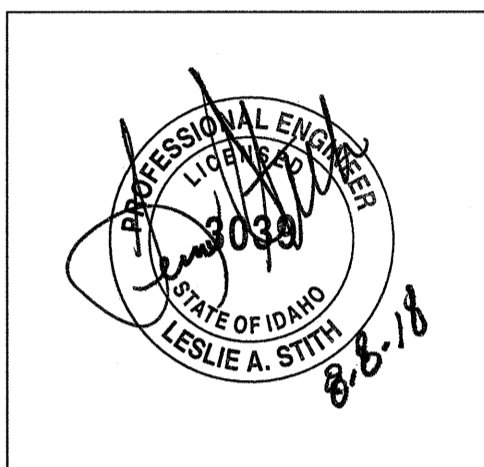

ADAMS COUNTY COMMUNITY CENTER
 MICHIGAN STREET
 COUNCIL, IDAHO

99U05	
Date:	8/8/2018
Drawn By:	JRR/KSL
Checked By:	STJ
Revisions	
▲	
▲	
▲	
▲	

eci
 Engineering Consultants Incorporated
 303 Federal Way Boise, Idaho 83705
 Phone (208) 376-9820 Fax (208) 376-9822
 www.eciboise.com

E1.1
 ELECTRICAL PLAN-OFFICES