


ELECTRICAL HVAC PLAN - MEZZANINE

SCALE: 1/8"=1'-0"



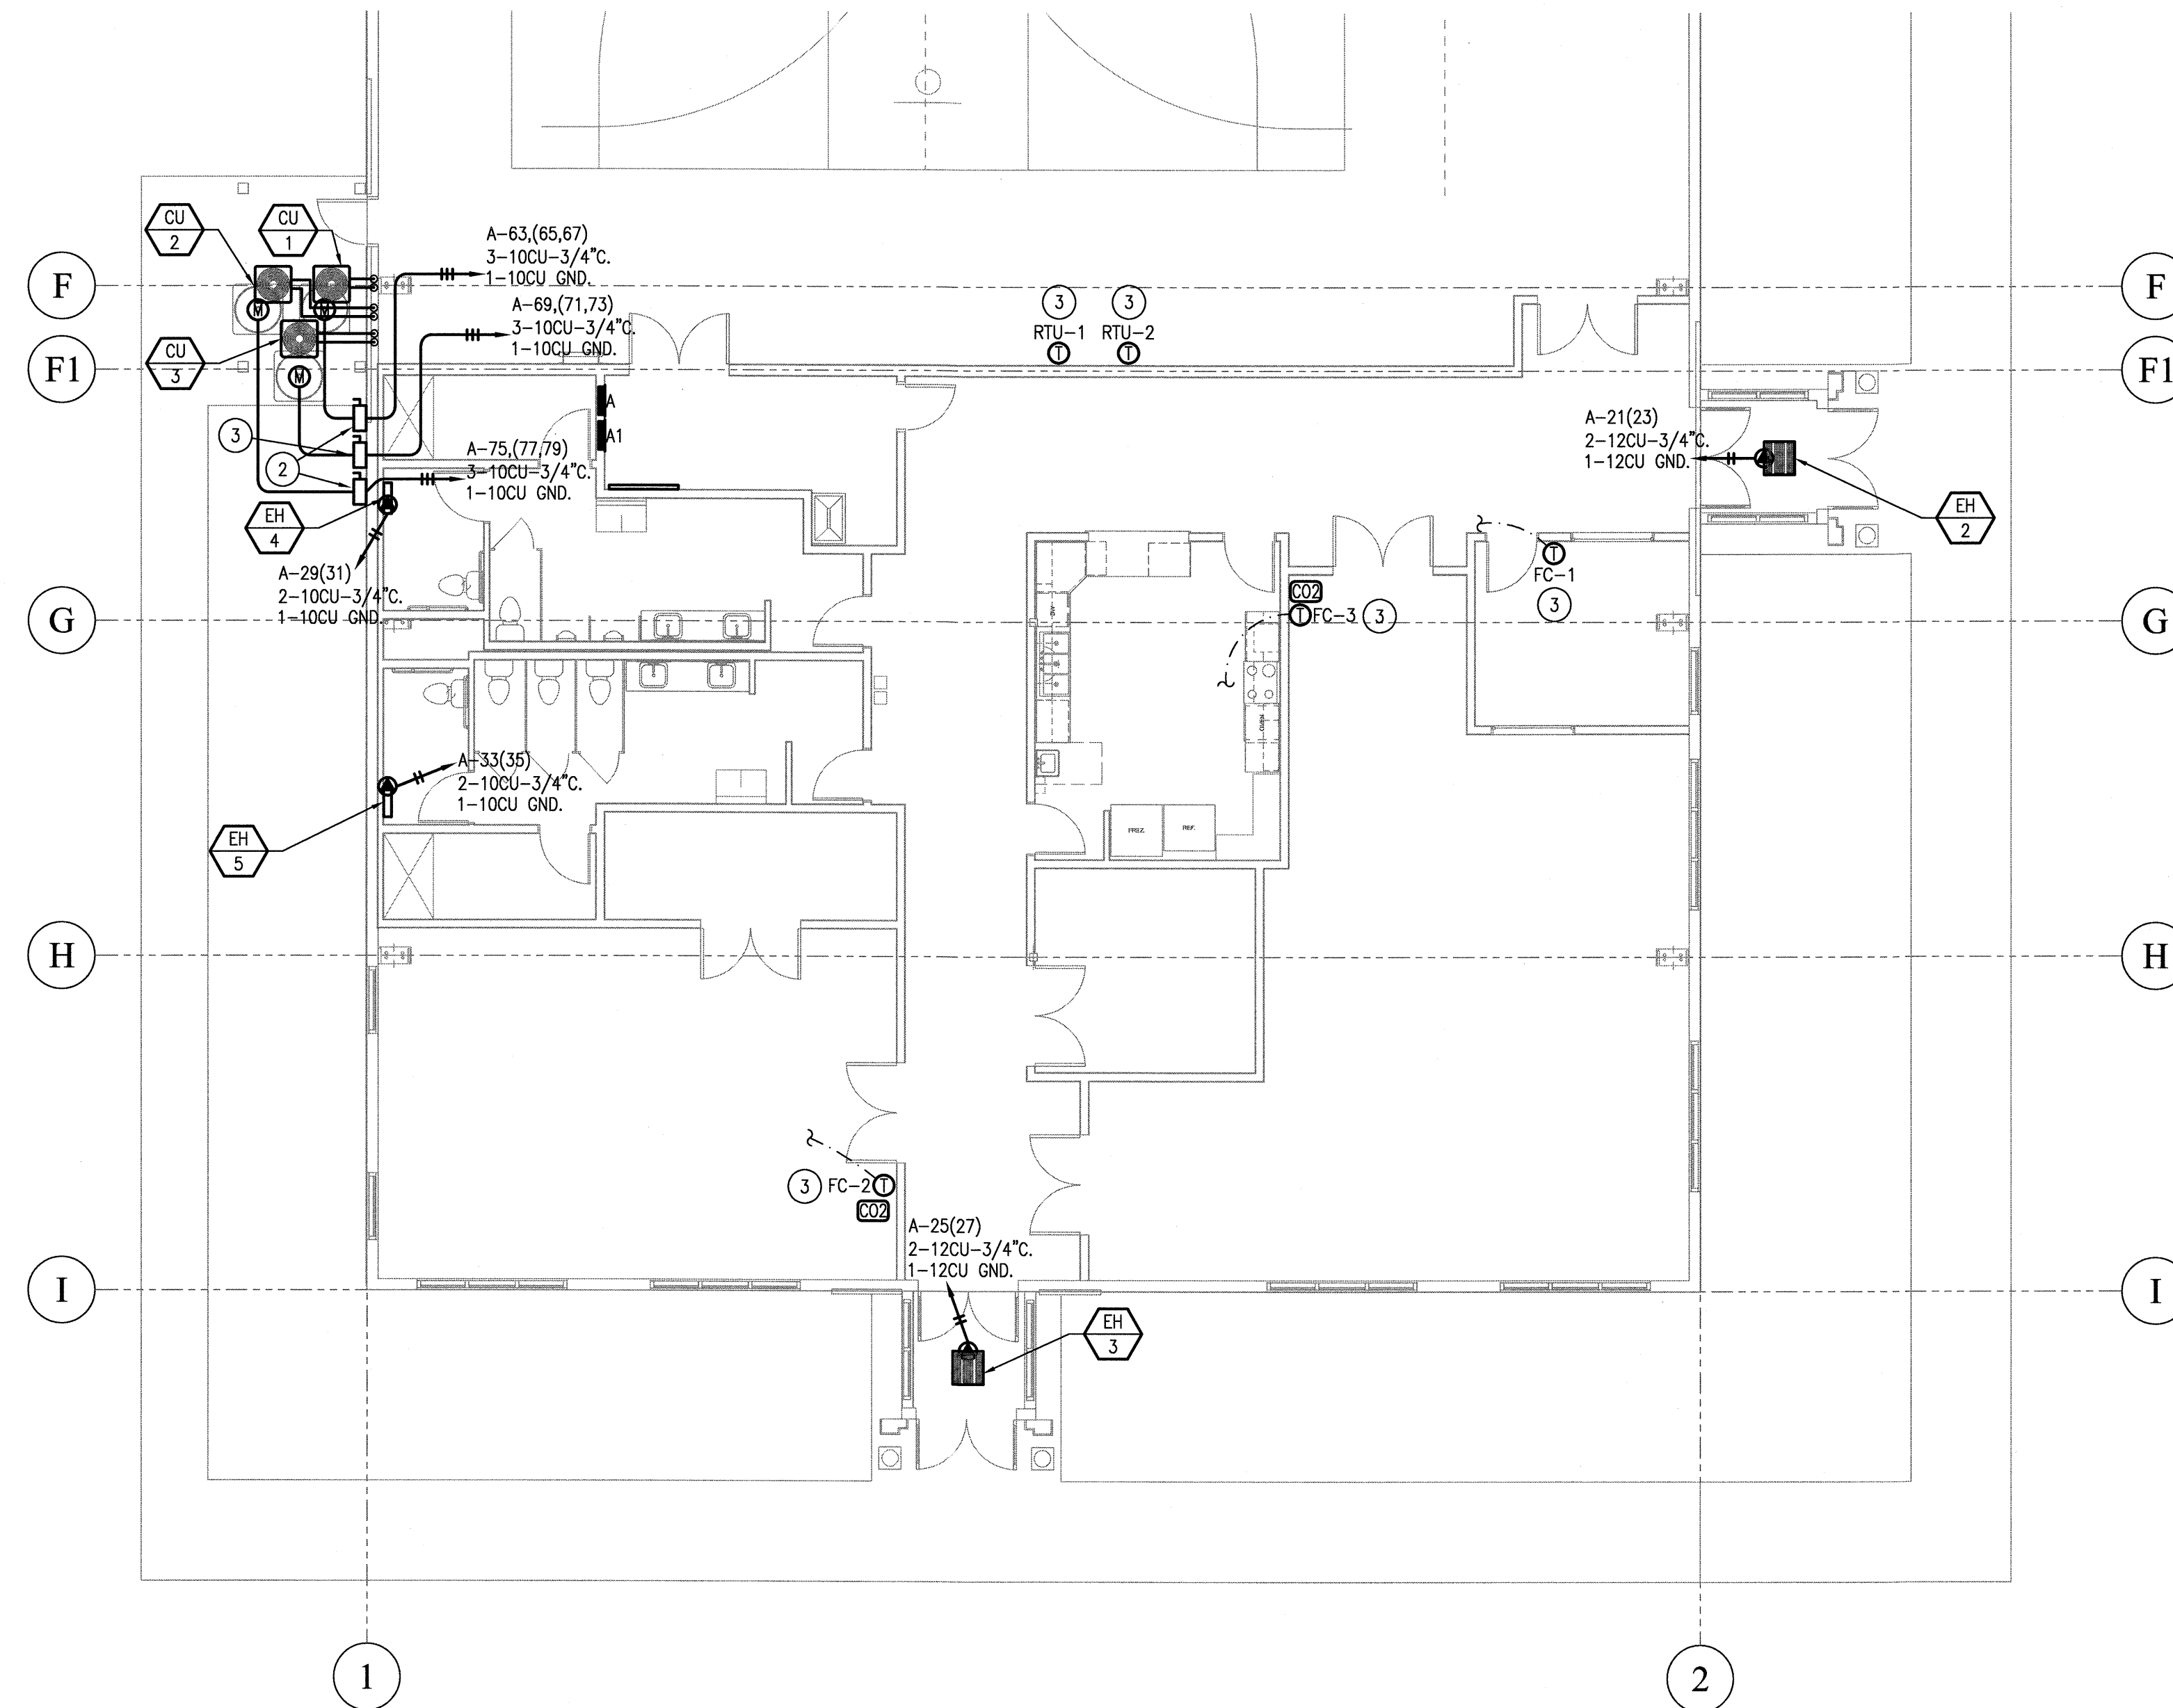


ELECTRICAL HVAC PLAN-OFFICES

SCALE: 1/8"=1'-0"

KEY NOTES:

1. NEMA "3R", 200/3 FUSED DISC. WITH 150A FRN FUSES. ELECTRICAL CONTRACTOR TO MAINTAIN ALL REQUIRED CLEARANCES.
2. NEMA "3R", 30/3 FUSED DISC. WITH 25A FRN FUSES. ELECTRICAL CONTRACTOR TO MAINTAIN ALL REQUIRED CLEARANCES.
3. TEMP. SENSOR T-STAT. MECHANICAL TO FURNISH AND INSTALL 1/2". TO ACCESSIBLE CEILING SPACE FOR CORRESPONDING MECHANICAL UNIT. COORDINATE EXACT LOCATION WITH MECHANICAL CONTRACTOR PRIOR TO ROUGH-IN.
4. INTERLOCK FAN WITH THERMOSTAT. PROVIDE ADDITIONAL RELAYS AS REQUIRED. SEE MECHANICAL FOR ADDITIONAL INFORMATION.
5. PROVIDE INTERCONNECT LOW VOLTAGE WIRING PER MANUFACTURER'S REQUIREMENTS. SEE MECHANICAL FOR MORE INFORMATION.
6. 120V CIRCUIT TO NEAREST SOURCE.
7. NEMA "3R", 30/3 FUSED DISC. WITH 30A FRN FUSES. ELECTRICAL CONTRACTOR TO MAINTAIN ALL REQUIRED CLEARANCES.

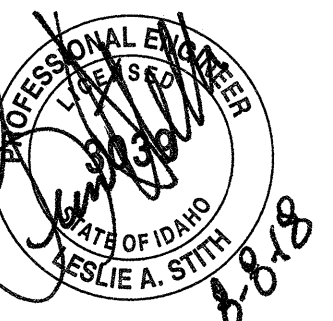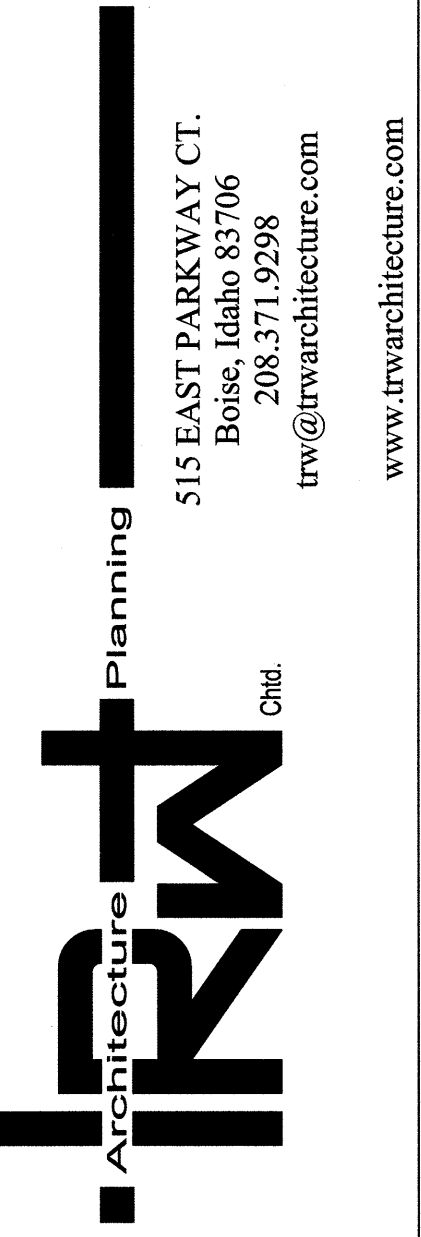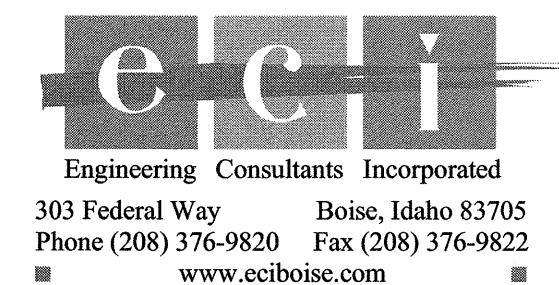

**ADAMS COUNTY COMMUNITY CENTER
MICHIGAN STREET
COUNCIL, IDAHO**

99U05

Date: 8/8/2018
Drawn By: JRR
Checked By: STJ

| Revisions | |
|-----------|--|
| ▲ | |
| ▲ | |
| ▲ | |
| ▲ | |

E2.1
ELECTRICAL HVAC
PLAN-OFFICES