


Light Fixture Schedule							
Type	Manufacturer	Model	Description	Voltage	Mounting	Lamp Type	Lamp Wattage
EX1	VA4	VA4-R-SA-AT	EXIT LIGHT	120	CEILING	LED	3.2
EX2	ARCHITECTURAL LIGHTING	PACO PEH	EMERGENCY LIGHT	120	WALL 7'-6" AFF	LED	1.5
EX3	ARCHITECTURAL LIGHTING	PACO PCH	EXIT/EMERGENCY LIGHT	120	WALL ABOVE DOOR	LED	1.5
FPL1	SAYLITE	SFL10L-50W-5562L-MV-120-50K-BZ	FLAG POLE FLOOD LIGHT	120	WALL	LED	50
	FLUORESCENTS		5562 LUMENS		13'8" AFF		
			5000K				
GL1	SAYLITE	FPPELP-24-50-DMV-WH-3S	2'x4' LED EDGELIGHT FLAT PANEL	120	GRID	LED	50
	FLUORESCENTS		8250 LUMENS				
			3500K, 80 CRI				
GL1E	SAYLITE	FPPELP-24-50-DMV-WH-3S-EM	2'x4' LED EDGELIGHT FLAT PANEL	120	GRID	LED	50
	FLUORESCENTS		6250 LUMENS		CEILING		3
			3500K, 80 CRI				
HL1	E2 LIGHTING	EZUFO 150W-5000K-D	LED HIGH BAY LIGHT	277	CEILING	LED	150
			15,502 LUMENS		14'-6" AFF		
			6000K				
HL2	E2 LIGHTING	EZUFO 150W-5000K-D	LED HIGH BAY LIGHT	277	CEILING	LED	150
			15,502 LUMENS		16'-0" AFF		
			5000K				
RL1	SAYLITE	SMCBL15W1100L30KWH	MICRO LED CYC 6" RECESSED	120	CEILING	LED	15
RL1E	FLUORESCENTS	SMCBL15W1100L30KWH-EM	ROUND 1100 LUMENS		SURFACE	LED	3
			3000K, 80 CRI				
VL1	SAYLITE	HOTBD-2-32-S-SN	VANITY LIGHT	120	WALL	F32T8	48
	FLUORESCENTS		FLUORESCENT CLOSE-TO-CEILING				
			WALL AND VANITY				
WL1	SAYLITE	209-A-48L-F32W3450L-DMV-40K	WRAFAROUND	120	CEILING	LED	32
	FLUORESCENTS		3818 LUMENS				
WP1	LUMATEQ	LW52-BR2-110-00	LED WALLPACK	120	WALL	LED	54
			4580 LUMENS		13'0" AFF		
			5700K, 80 CRI				
WP2	BARRON	TLED-NFM-42-VS-5K-EM	DARK BRONZE EGRESS LIGHT	120	WALL	F32T8	41.6
	LIGHTING		4080 LUMENS		10'0" AFF		3

- FIXTURE NOTE:**
- PROVIDE ELECTRONIC BALLASTS AND T-8 LAMPS
 - NOT USED
 - THIS FIXTURE IS PROVIDED WITH EMERGENCY BATTERY.
 - PROVIDED BY OWNER.

FIXTURE NOTE:

APPROVAL IS FOR MANUFACTURER ONLY, NOT SPECIFIC MODEL NUMBERS. PHYSICAL AND ELECTRICAL REQUIREMENTS MUST BE COORDINATED. EQUIPMENT IS STILL REQUIRED TO BE EQUAL OR BETTER THAN THAT ORIGINALLY SPECIFIED, AND MUST MEET PERFORMANCE AND OPERATING REQUIREMENTS.

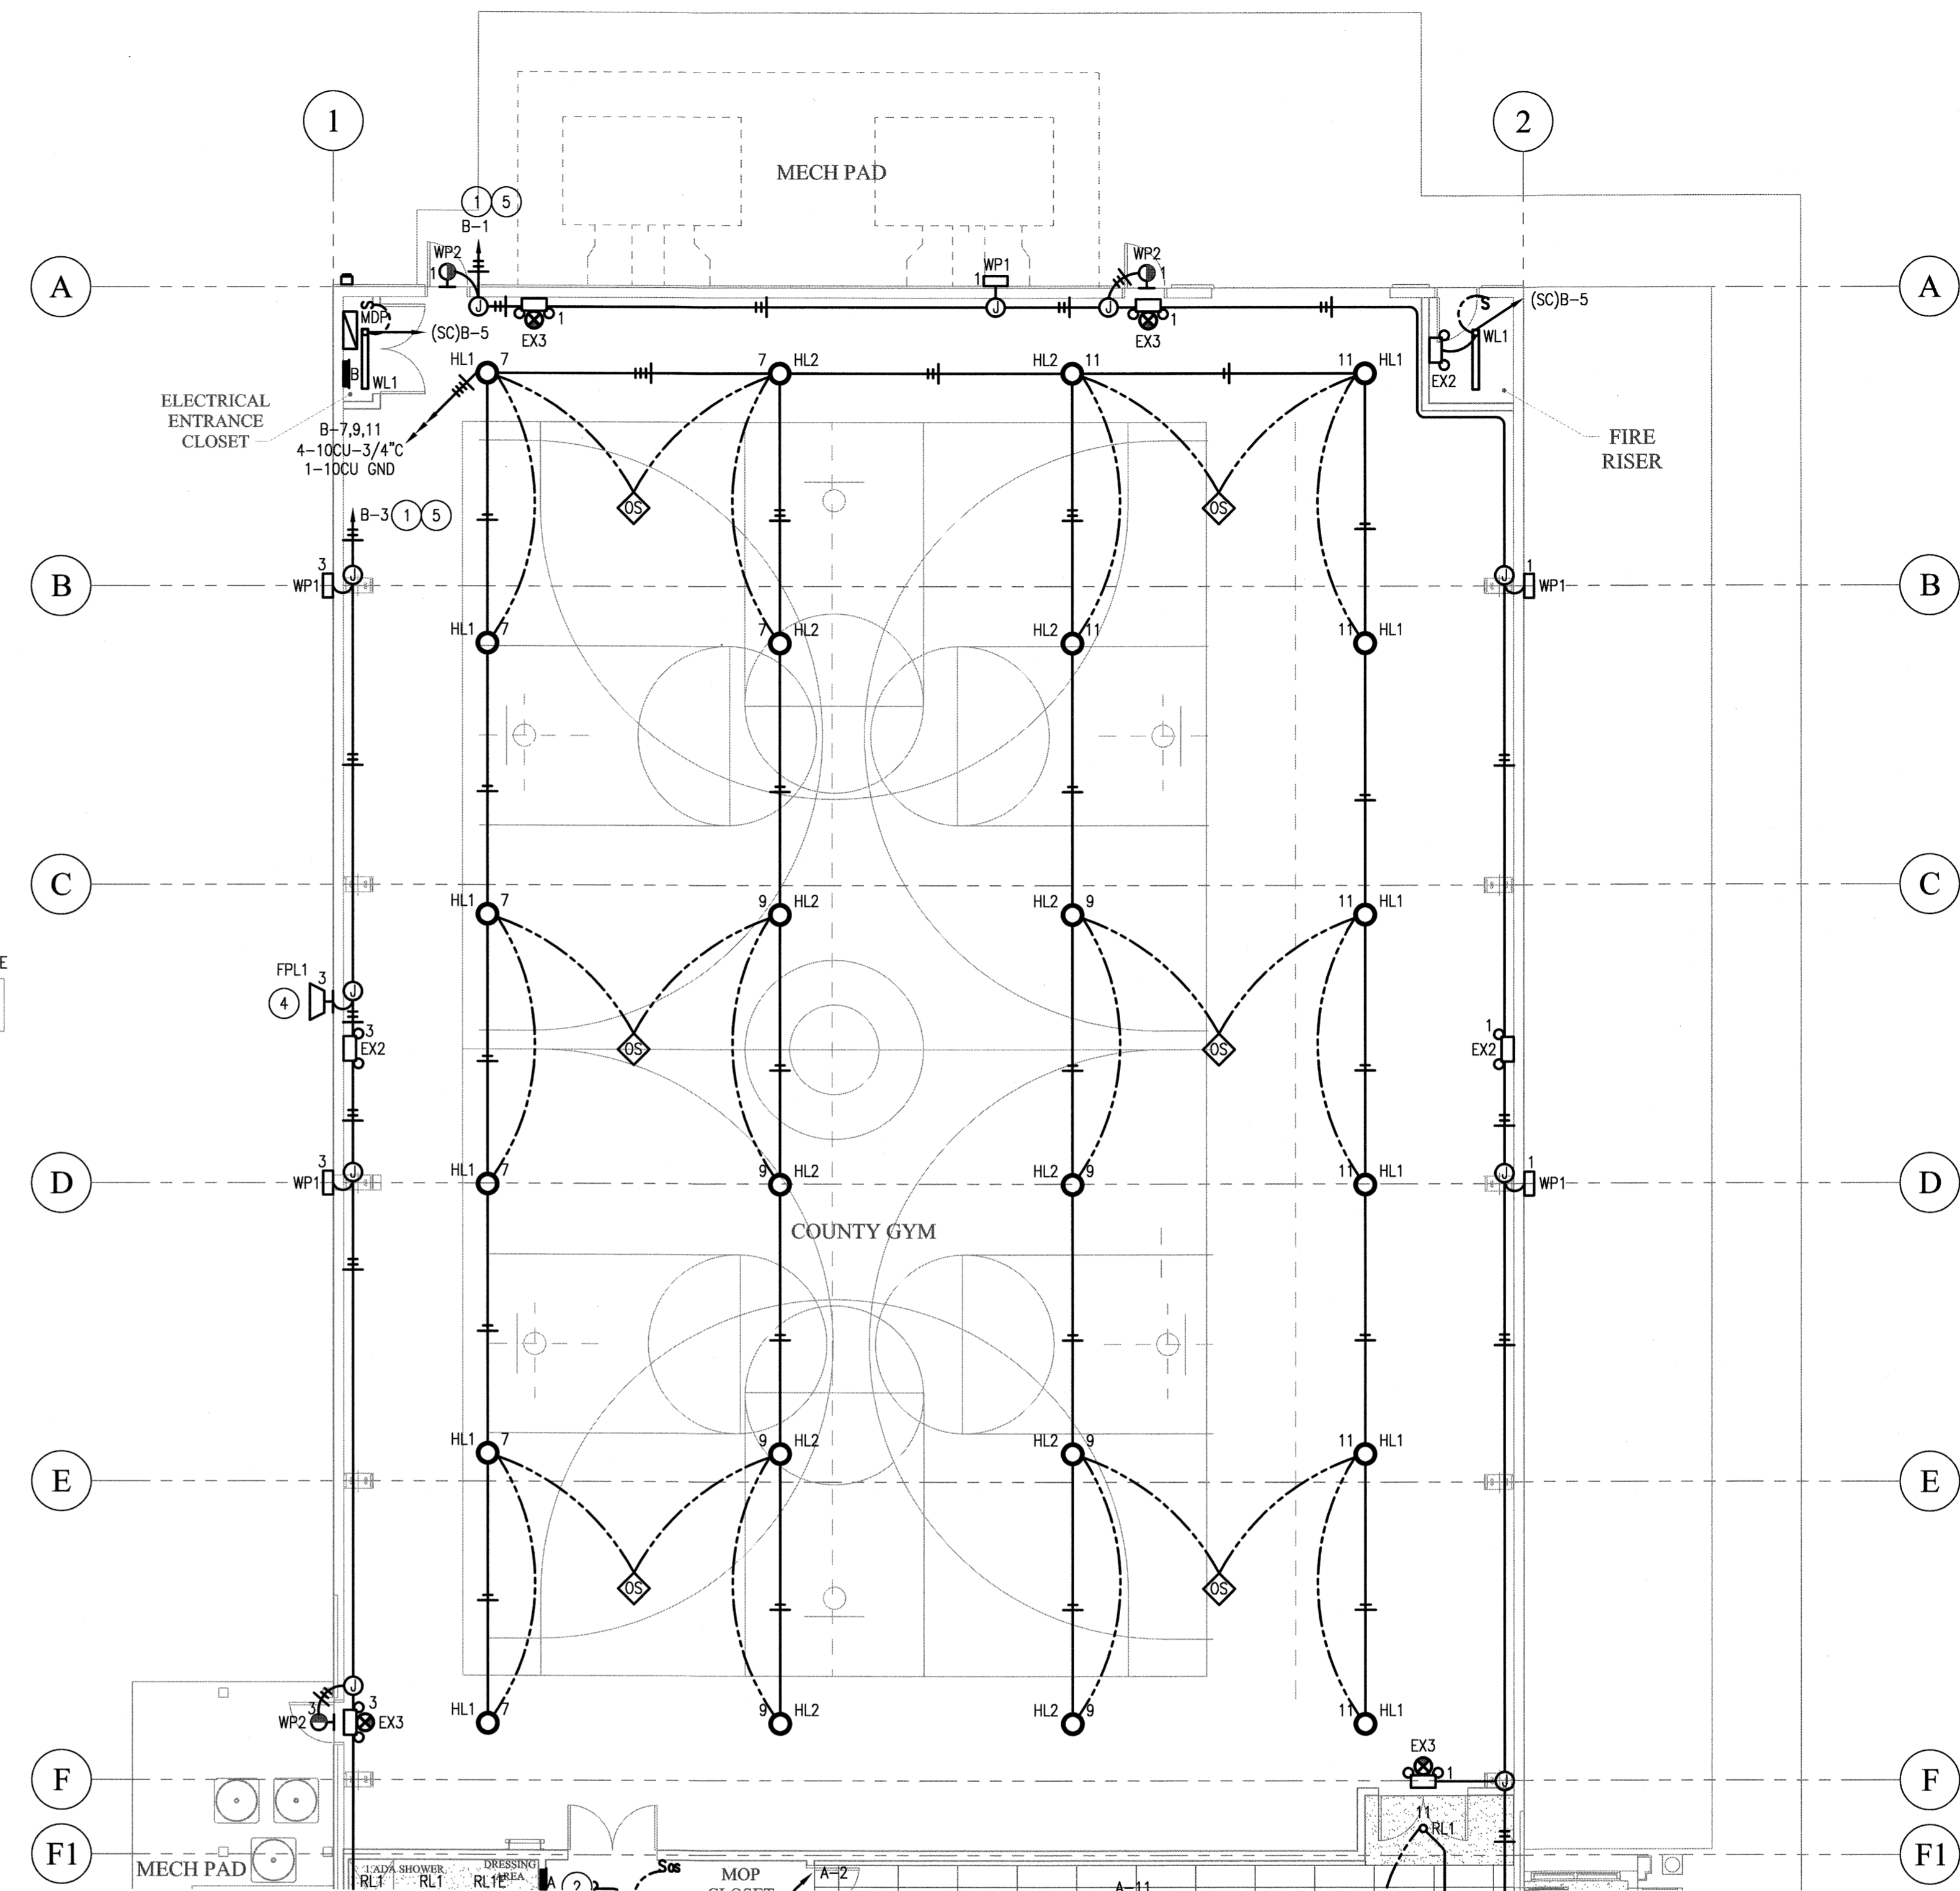


LIGHTING PLAN-GYM
SCALE: 1/8"=1'-0"

KEY NOTES:

- PROVIDE ADDITIONAL UNSWITCHED HOT LEG FOR EMERGENCY BATTERY PACKS TO KEEP CHARGED.
- SEE MEZZANINE PLAN THIS SHEET FOR CONTINUATION.
- SEE MAIN PLAN JANITOR CLOSET THIS SHEET FOR CONTINUATION.
- AIM FLAG POLE LIGHT AT EXISTING FLAG POLE FOR BEST ILLUMINATION.
- ROUTE CIRCUIT THRU CONTACTOR FOR TIME CLOCK CONTROL.

TRW Architecture Planning
515 EAST PARKWAY CT.
Boise, Idaho 83706
208.371.9298
trw@trwarchitecture.com
www.trwarchitecture.com

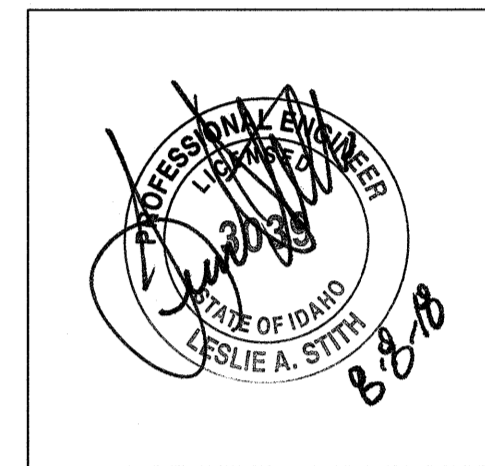

ADAMS COUNTY COMMUNITY CENTER
MICHIGAN STREET
COUNCIL, IDAHO

99U05

Date: 8/8/2018

Drawn By: JRR

Checked By: STJ

Revisions

eci
Engineering Consultants Incorporated
303 Federal Way Boise, Idaho 83705
Phone (208) 376-9820 Fax (208) 376-9822
www.eciboise.com

E3.2
LIGHTING PLAN-GYM